



M.E. RINKER, Sr. HALL
SCHOOL OF BUILDING CONSTRUCTION
 UNIVERSITY OF FLORIDA-GAINESVILLE
 PROJECT NO. BR-191

- POWER PLAN NOTES:**
1. REFER TO DWG E001 FOR SYMBOLS, AND ABBREVIATIONS.
 2. REFER TO DWG E003 FOR ONE-LINE DIAGRAM.
 3. REFER TO DWG E004 FOR RISER DIAGRAM.
 4. REFER TO DWG E004 FOR PANEL SCHEDULES.
 5. REFER TO DWG E006 FOR FIRE ALARM SYSTEM RISER.
 6. REFER TO CLASSROOM ELEVATIONS ON ARCHITECTURAL DRAWINGS FOR AV PANEL AND SWITCH LOCATIONS.

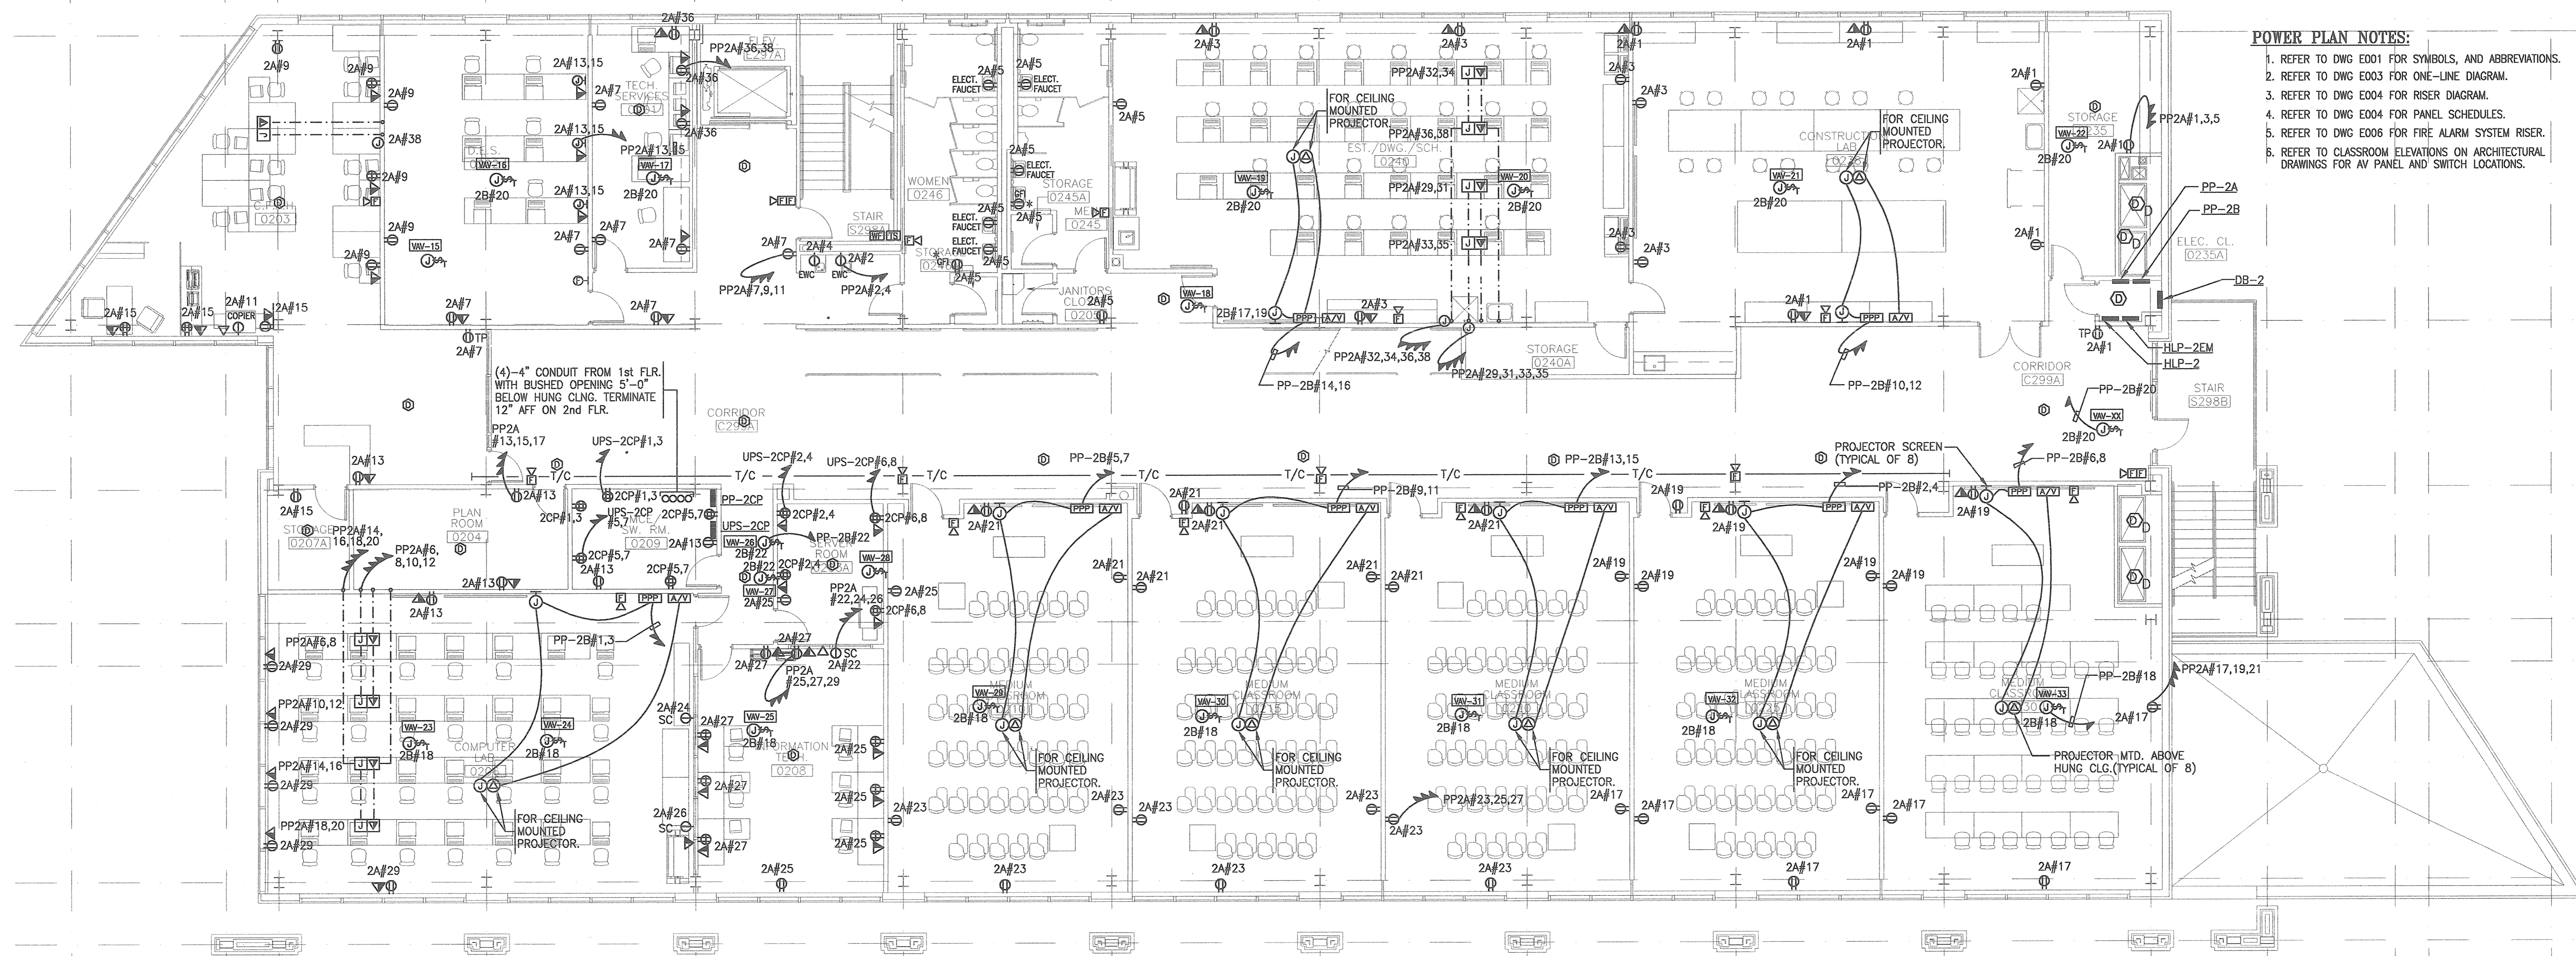


SECOND FLOOR PLAN
 SCALE: 1/8"=1'-0"

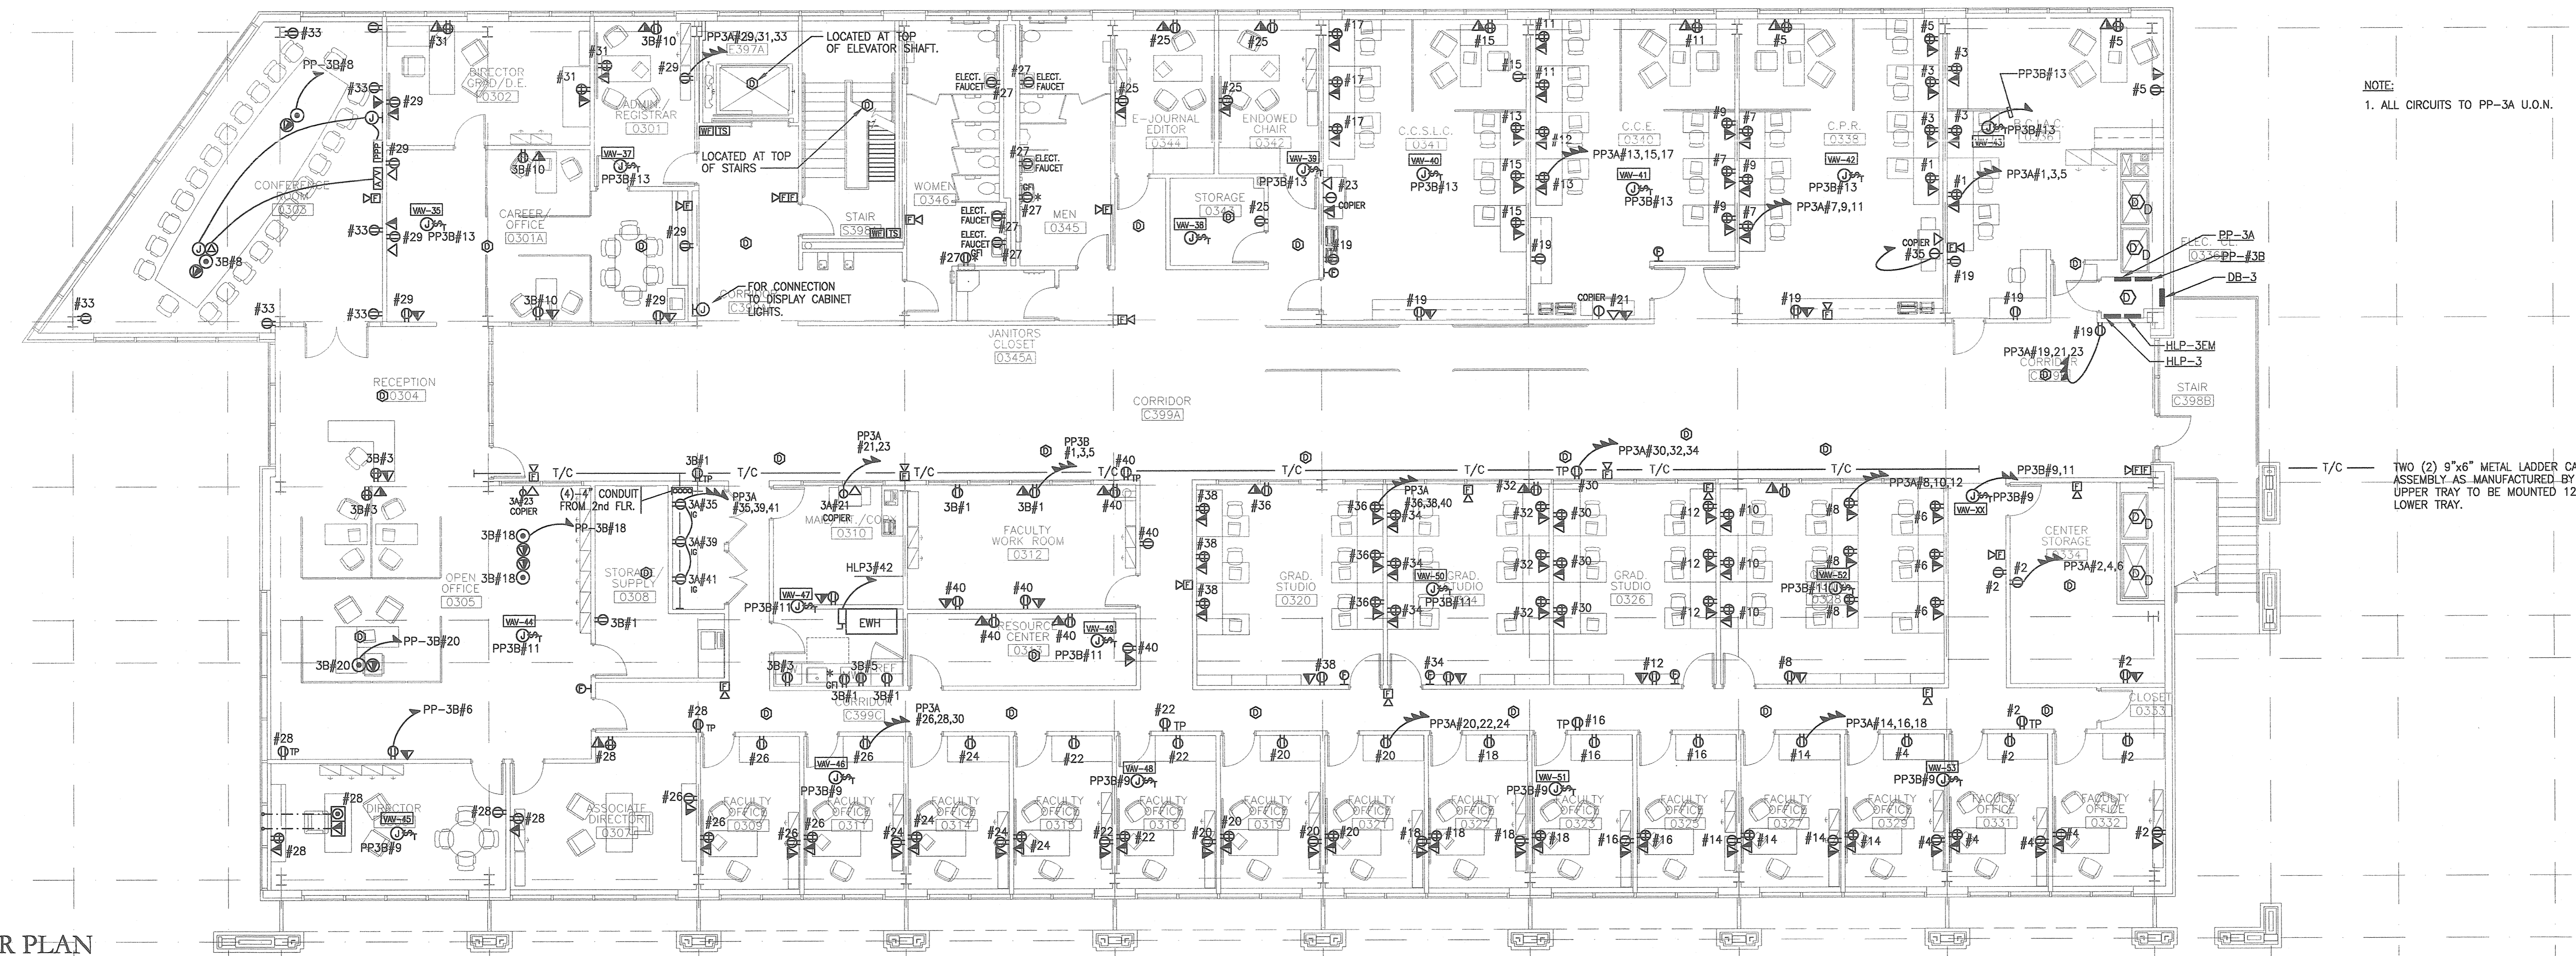

THIRD FLOOR PLAN
 SCALE: 1/8"=1'-0"

NOTE:
 1. ALL CIRCUITS TO PP-3A U.O.N.

NOTE:
 TWO (2) 9"x6" METAL LADDER CABLE TRAY ASSEMBLY AS MANUFACTURED BY B-LINE UPPER TRAY TO BE MOUNTED 12" ABOVE LOWER TRAY.

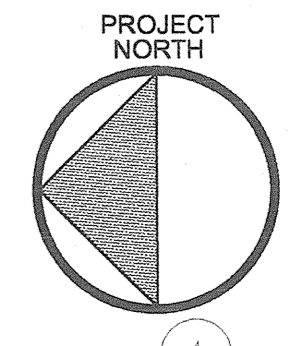

ARCHITECTS:
 CROXTON COLLABORATIVE/
 GOULD EVANS ASSOCIATES
 CROXTON COLLABORATIVE ARCHITECTS
 475 FIFTH AVENUE
 NEW YORK, NY 10017
 TEL 212-683-1998
 FAX 212-683-2799

GOULD EVANS ASSOCIATES
 5405 WEST CYPRESS STREET
 TAMPA, FL 33607
 TEL 813-288-0729
 FAX 813-288-0231

MECHANICAL ENGINEERS:
 LEHR ASSOCIATES
 130 WEST 30TH STREET
 NEW YORK, NY 10001-4092
 TEL 212-947-8858
 FAX 212-967-2959

STRUCTURAL ENGINEER:
 WALTER P. MOORE
 201 EAST KENNEDY BOULEVARD
 TAMPA, FL 33602
 TEL 813-221-2424
 FAX 813-221-2289

CIVIL ENGINEERS:
 BROWN & CULLEN, INC.
 3536 NW 43 STREET
 GAINESVILLE, FL 32605
 TEL 352-375-8999
 FAX 352-375-0833

LANDSCAPE ARCHITECTS:
 McCLAIN DESIGN GROUP, INC.
 1843 NW 39 DRIVE
 GAINESVILLE, FL 32605
 TEL 352-372-2808
 FAX 352-372-6622

CONSULTANT:
 SEEGER-BISCH
 AUSSERE SULZBACHER STR. 118
 MUMBERG, GERMANY
 TEL 0911/59 98 99
 FAX 0911/59 98 05

THIS DRAWING, AS AN INSTRUMENT OF SERVICE, IS AND SHALL REMAIN PROPERTY OF CROXTON COLLABORATIVE ARCHITECTS. THIS DRAWING SHALL NOT BE REPRODUCED, PUBLISHED, USED IN OTHER PROJECTS, USED FOR ADDITIONS, OR USED IN COMPLETION OF THIS PROJECT BY OTHERS EXCEPT BY AGREEMENT IN WRITING. ©2011 CROXTON COLLABORATIVE ARCHITECTS/GOULD EVANS ASSOCIATES.

100% CONSTRUCTION DOCUMENTS

ELECTRICAL SECOND AND THIRD FLOOR POWER PLAN

DATE: 11/21/01
 SCALE: 1/8"=1'-0"
 DRAWN BY/CHECKED BY: NA/JH
E103P

C:\1440\EE\1440E103P_282.dwg Nov 19, 2001 - 16:14:53 imported